

PVA ARCHITECT
49 Old Creamery Road
Newton NJ 07860


P.V.A.
Paul V. Ashworth AIA NCARB
NJ Lic. #: 21A01817800

ALL DRAWINGS AND WRITTEN MATERIALS APPEARING HEREIN CONSTITUTE ORIGINAL AND UNPUBLISHED WORK OF THE ARCHITECT. THE REPRODUCTION OF THIS DRAWING FOR THE PURPOSE OF COPYING THIS WORK, OR REVISIONS THEREOF, SHALL BE CONSIDERED A VIOLATION OF BOTH THE PROFESSIONAL CODE OF ETHICS AND A TRUST OF COMPANY ASSETS, BOTH OF WHICH SHALL BE PROSECUTED TO THE FULLEST EXTENT OF THE LAW AND CURRENT STATUTES.




NO.	DESCRIPTION	DATE

PROPOSED SITE PLAN FOR:
46-48 GROVE N PLAINFIELD LLC
46-48 GROVE STREET
NORTH PLAINFIELD NEW JERSEY 07060-4711
LOT 15.01 / BLOCK 91

DATE ISSUED: 2022-09-20
SCALE: AS NOTED
DRAWN BY: VP
CHECKED BY: PVA
FILE NAME: 46-48 GROVE
PROJECT NUMBER: 22-39
DRAWING NUMBER:
C-1




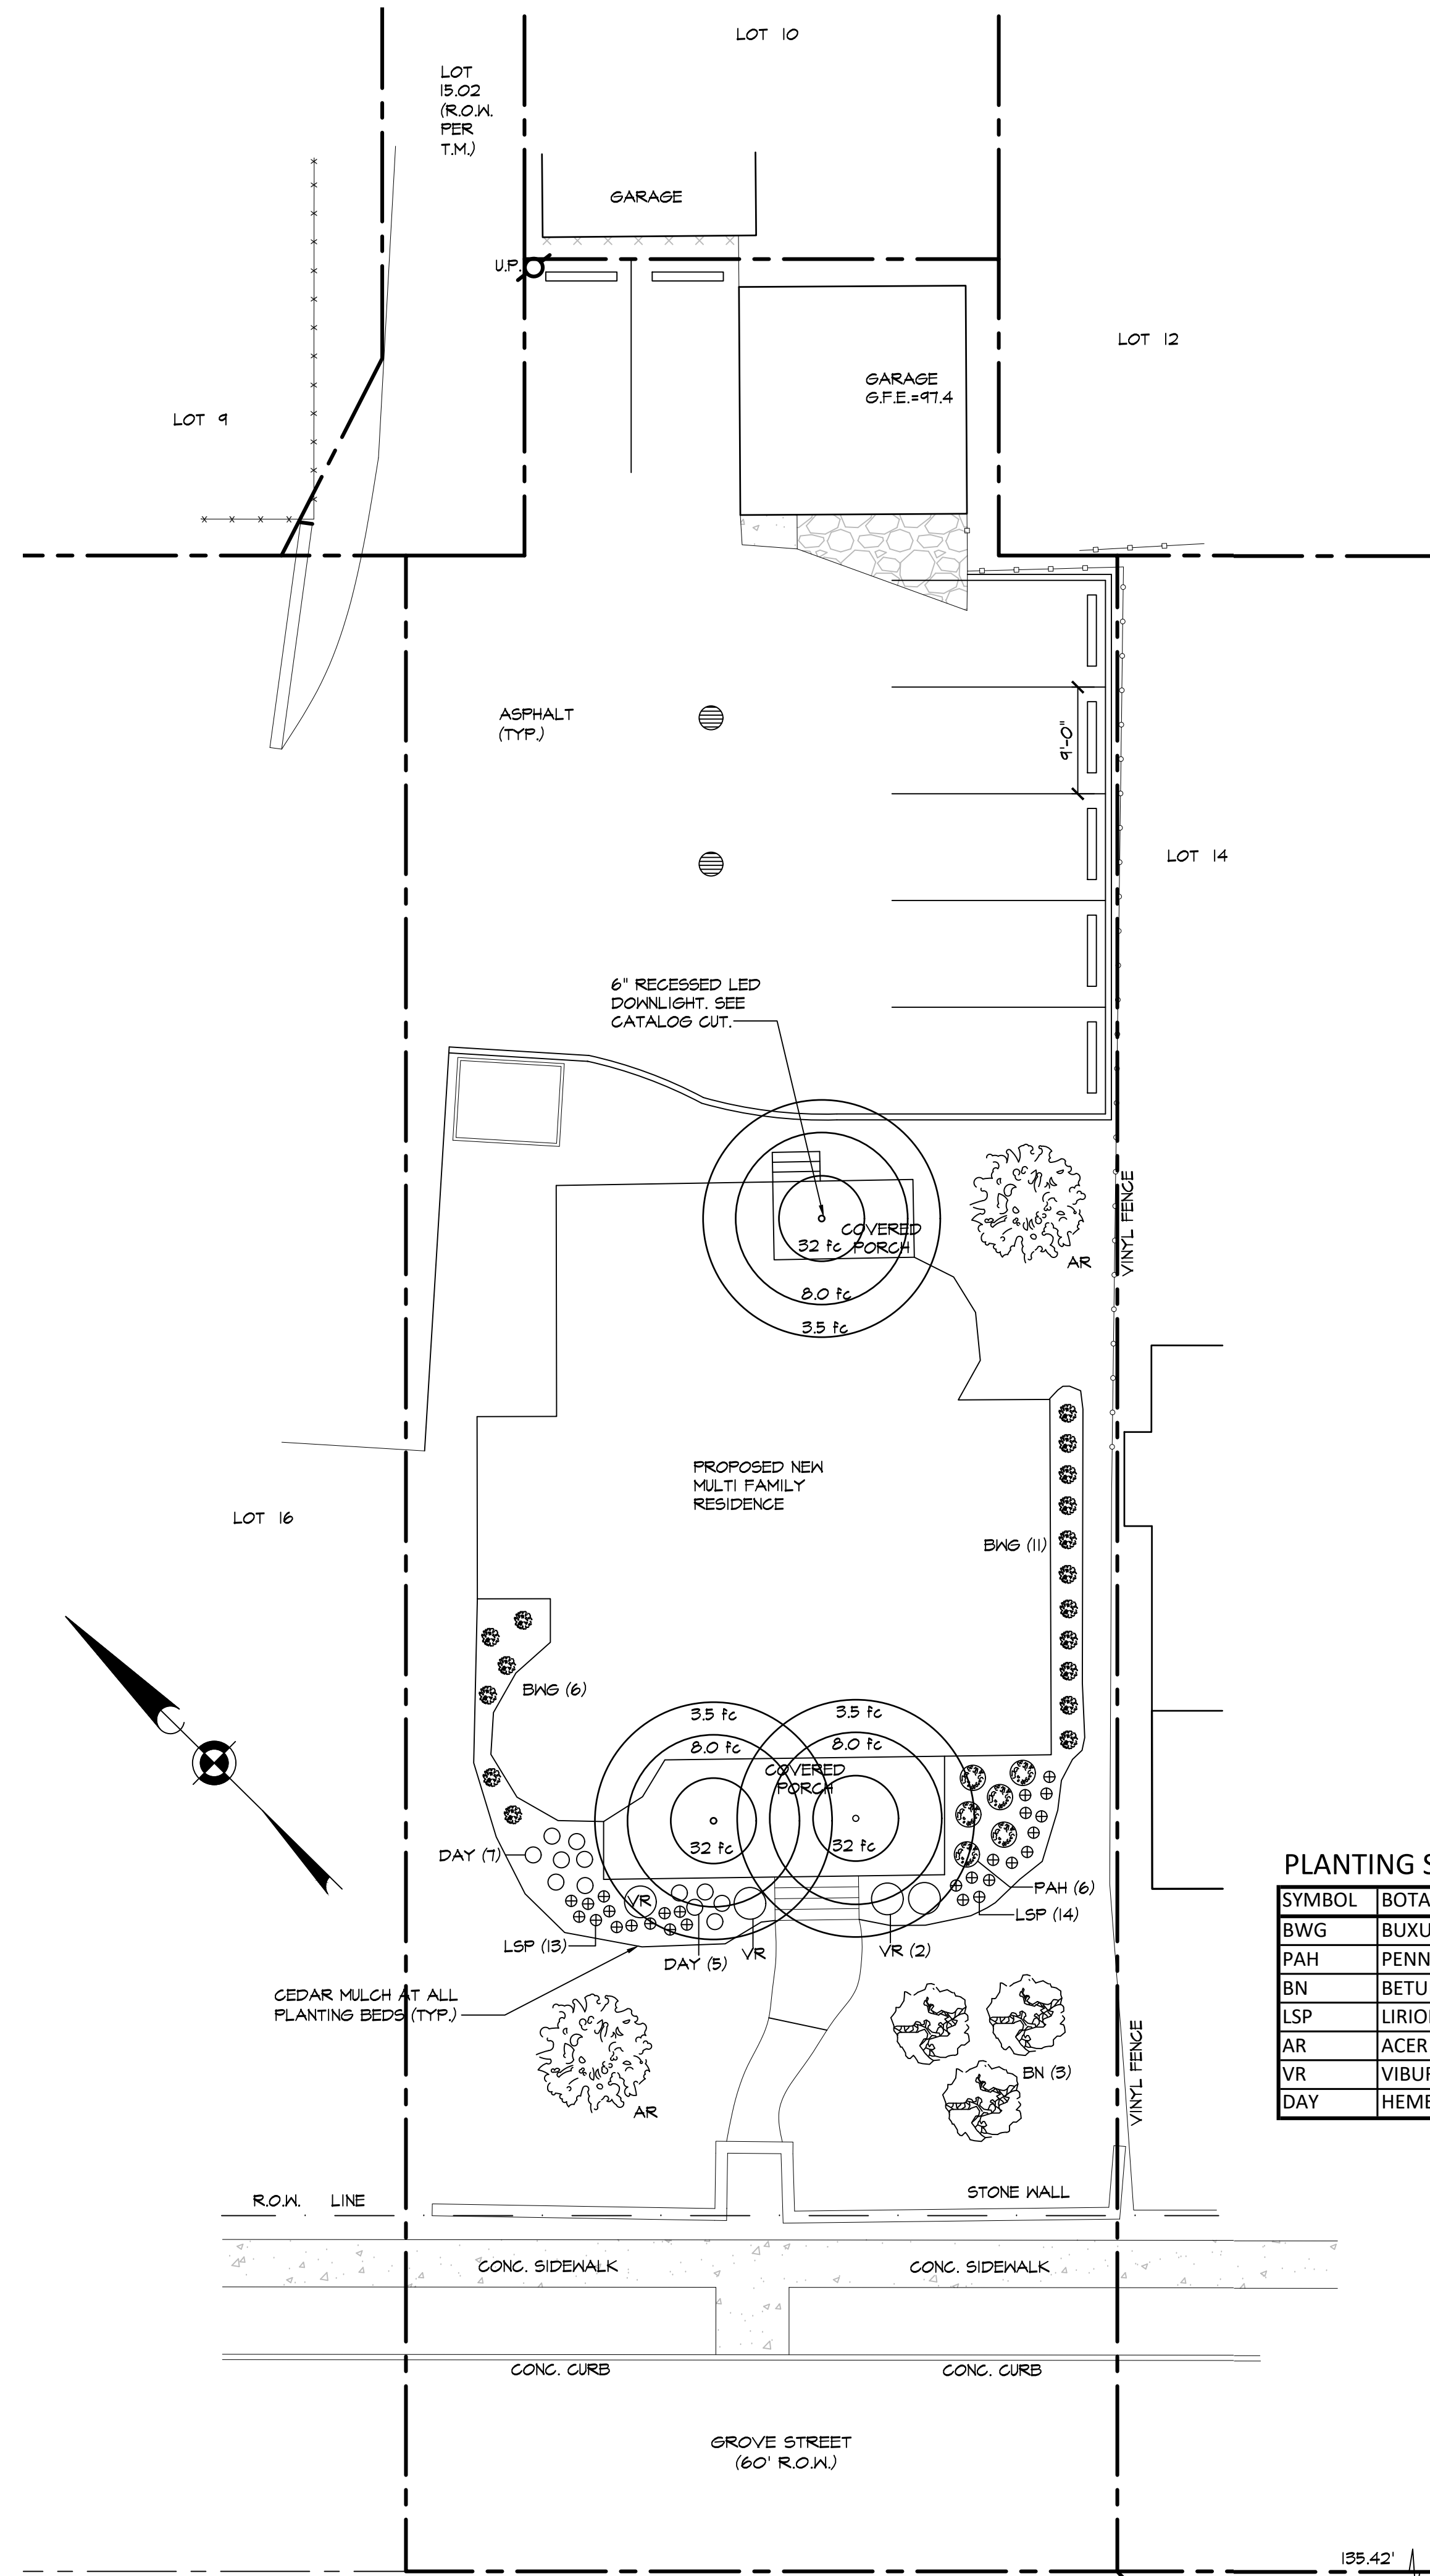


LANDSCAPING AND LIGHTING PLAN
SCALE: 1" = 10'-0"

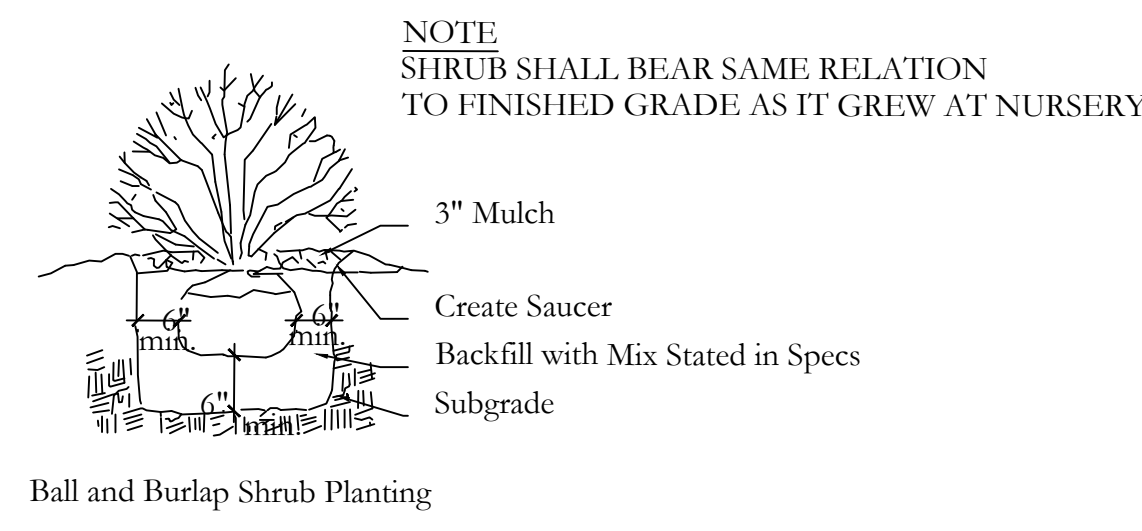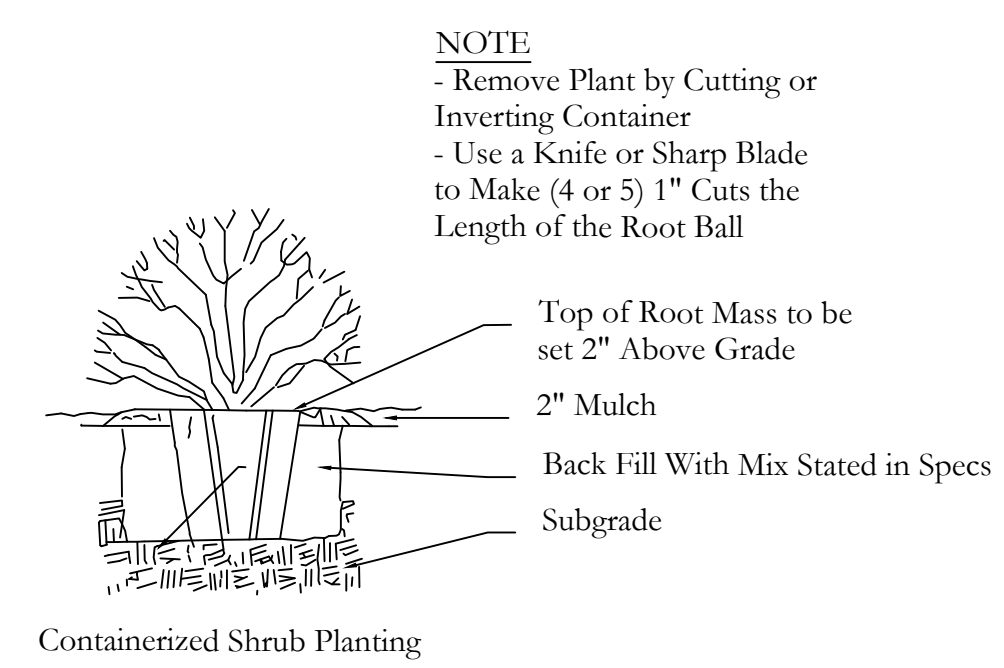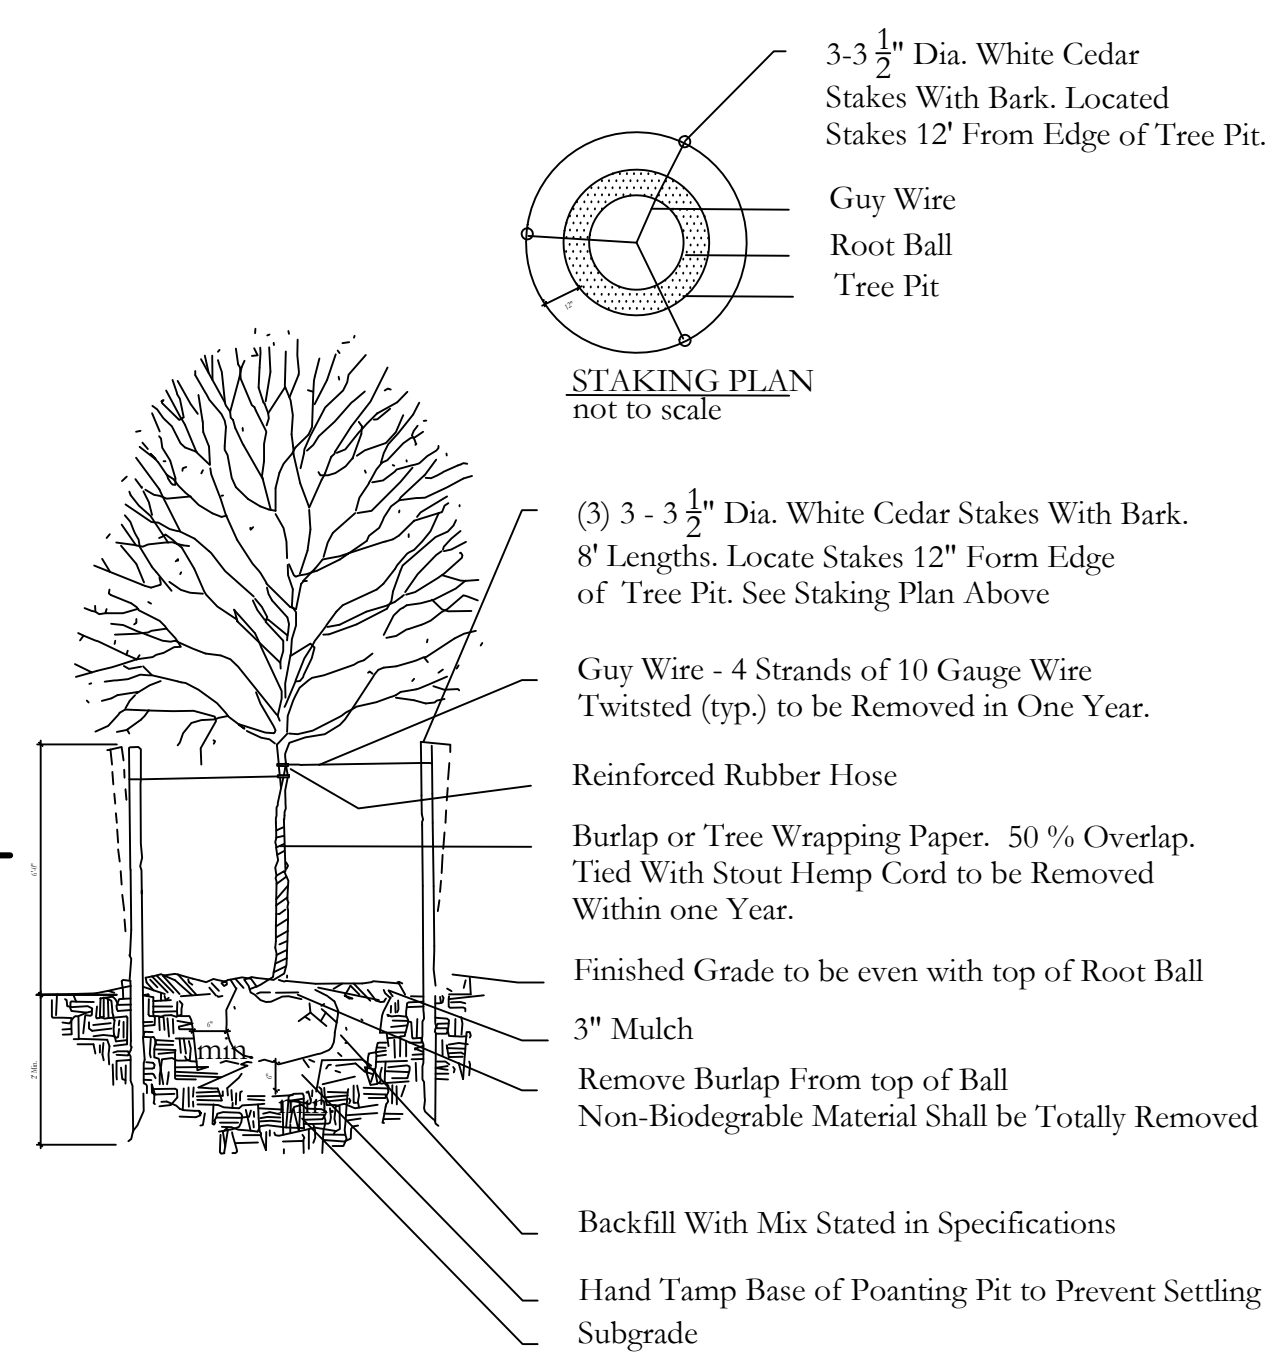

PLANTING SCHEDULE

SYMBOL	BOTANICAL NAME	COMMON NAME	SIZE
BWG	BUXUS 'WINTER GEM'	WINTER GEN BOXWOOD	18"-24" HT
PAH	PENNISSETUM ALOPECUROIDES 'HAMELI'	ROSE FOUNTAIN GRASS	1 GAL
BN	BETULA NIGRA	RIVER BIRCH	10'-12' CLUMP
LSP	LIRIOPE SPICATA	LILY TURF	1 GAL
AR	ACER RUBRUM 'OCTOBER GLORY'	RED MAPLE	2.5" CAL.
VR	VIBURNUM RHYTIDOPHYLLUM	LEATHERLEAF VIBURNUM	36"-42" HT
DAY	HEMEROCALLIS STELLA DE ORA	STELLA DE ORO DAYLILIE	1 GAL

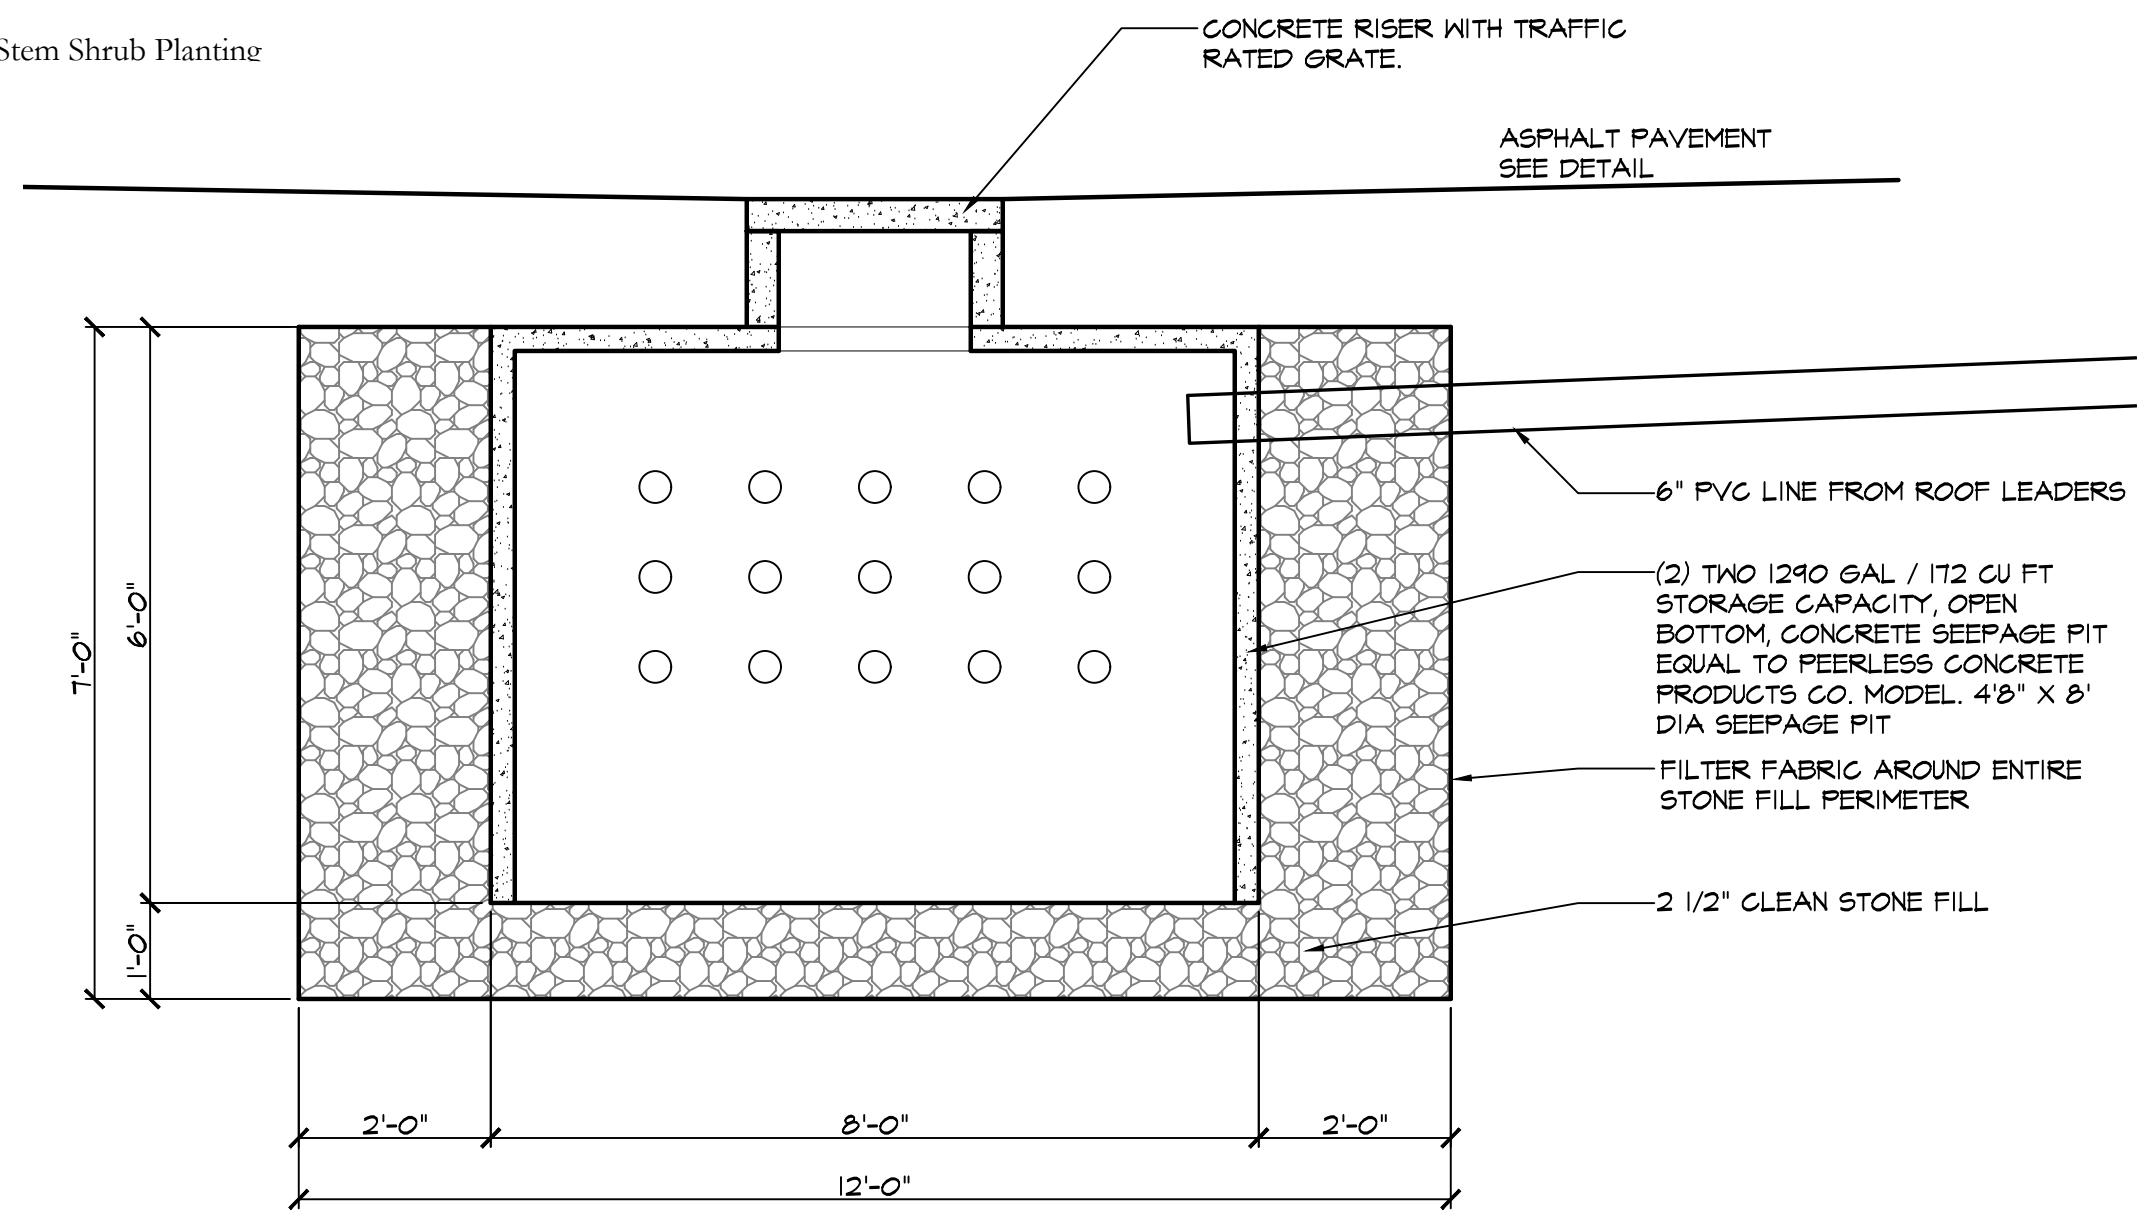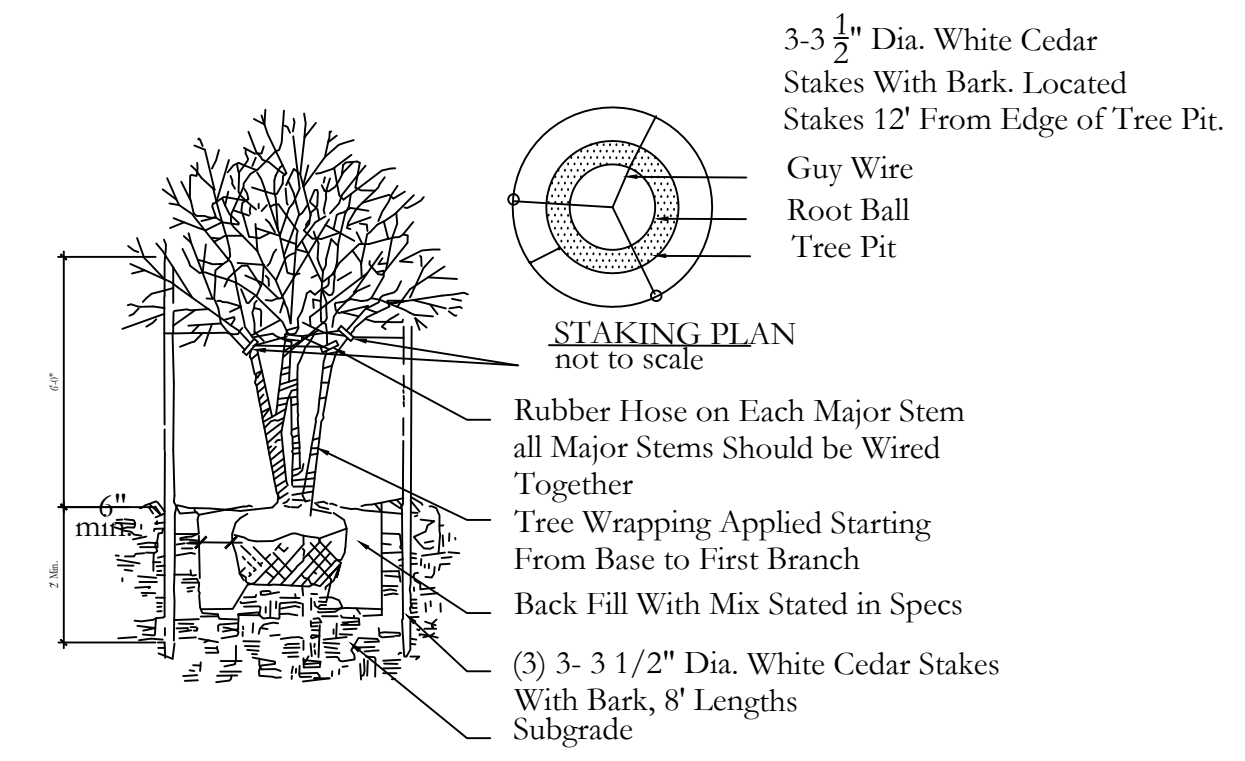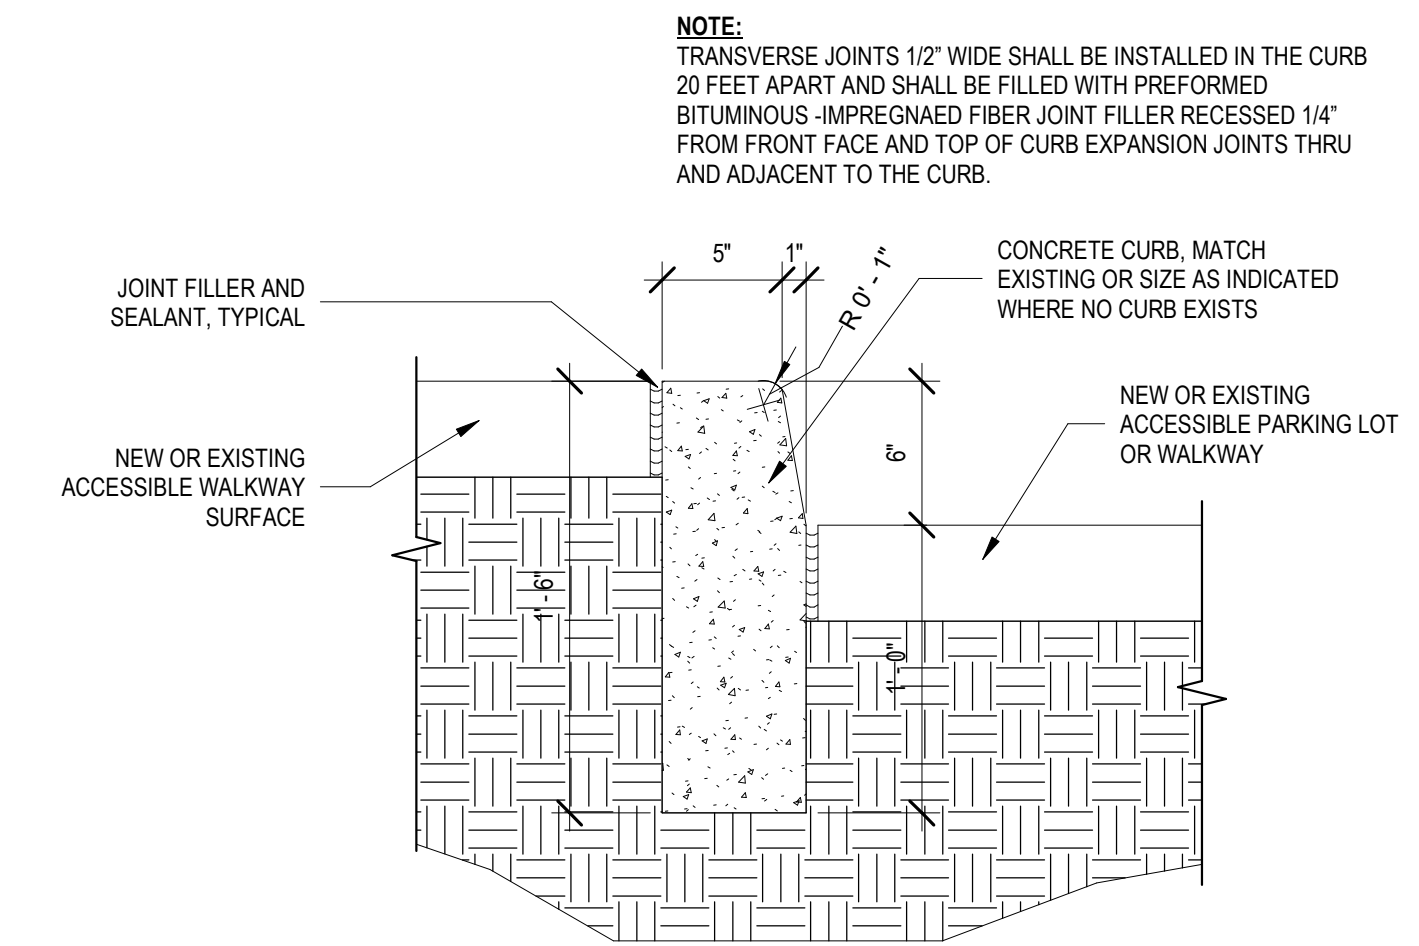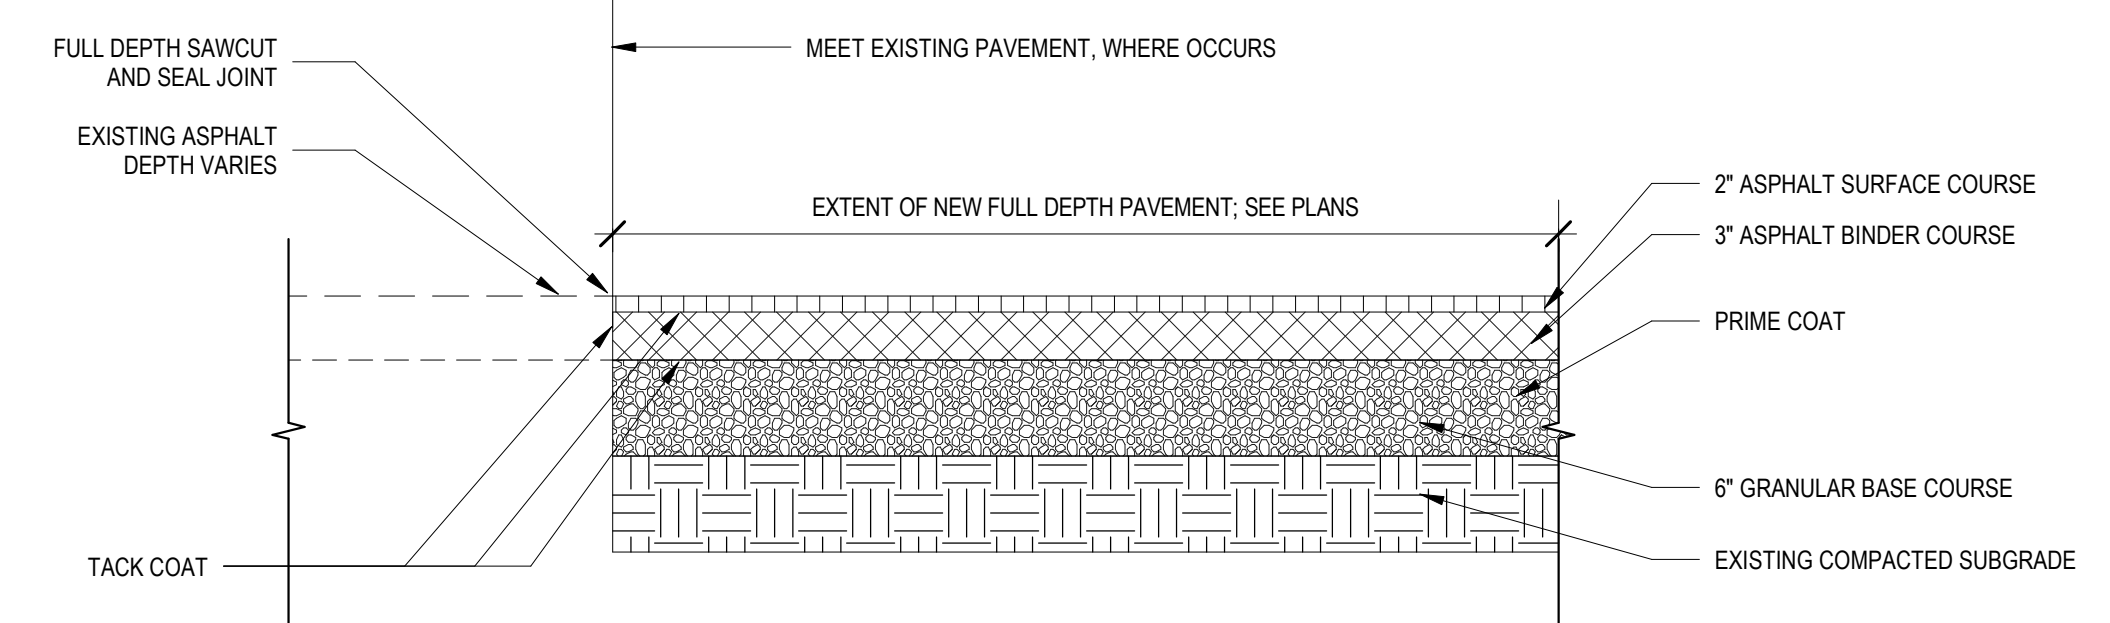

NO.	DESCRIPTION	DATE

